

NOTES:
 All dimensions in metres.
 Do not scale from drawing.
 For any discrepancies found please consult with design office.
 This drawing should be read in conjunction with all contract drawings, documents and specifications.


LEGEND:

Lighting Columns: A B C D

Lighting Contours: [Color-coded lines]

Treescape Heights (m) Blueskyreland surveys:

- ✓ 0.3 - 4.2
- ✓ 4.2 - 6.4
- ✓ 6.4 - 9.6
- ✓ 9.6 - 13.9
- ✓ 13.9 - 25.9


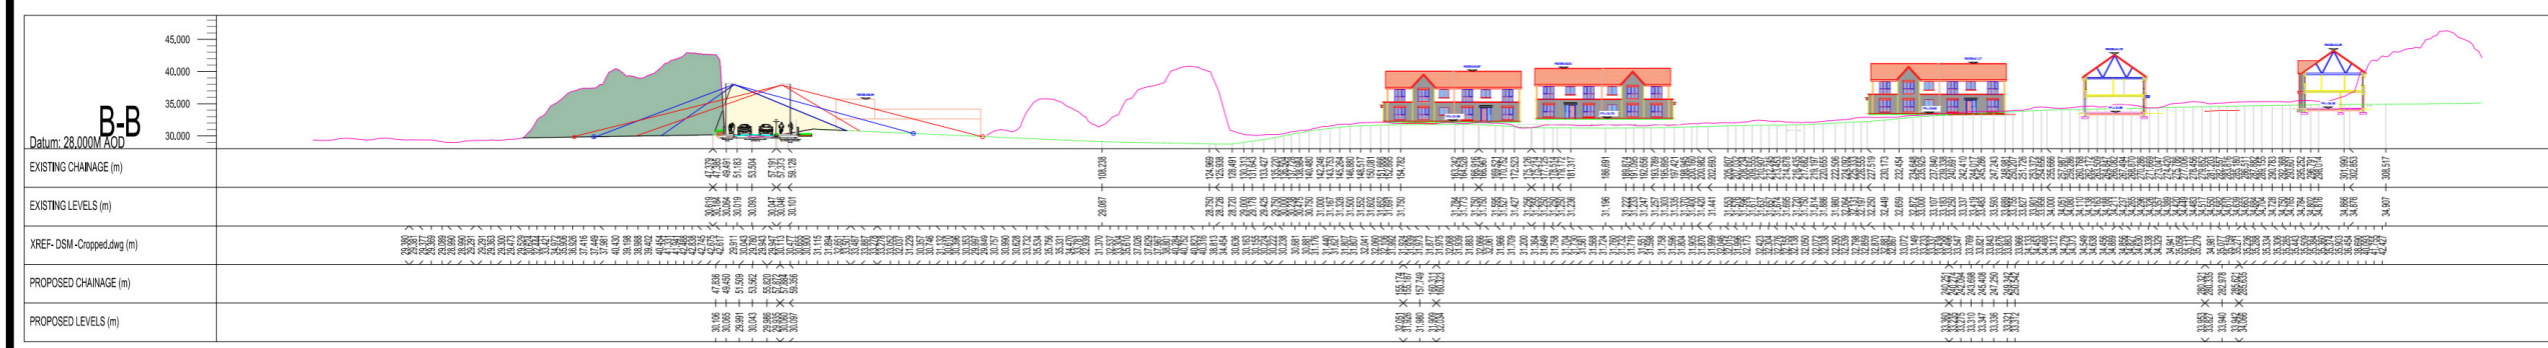


Estimated son Lighting Spread extents [Red line]

Proposed M4 LED Lighting Spread extents [Blue line]

Cross section [Black line]

SCALE: NTS

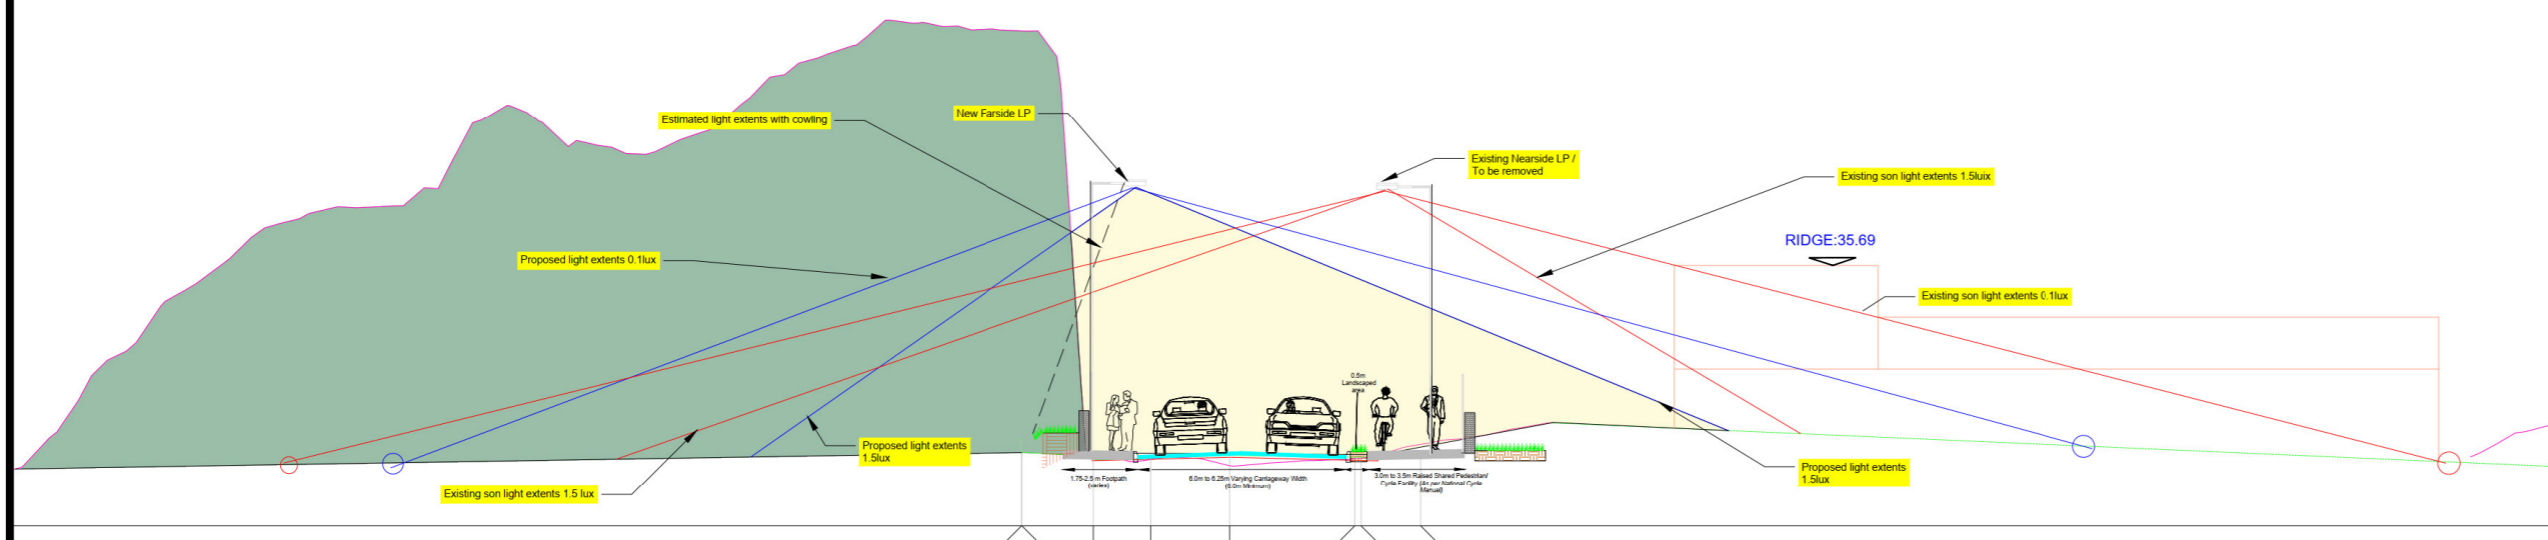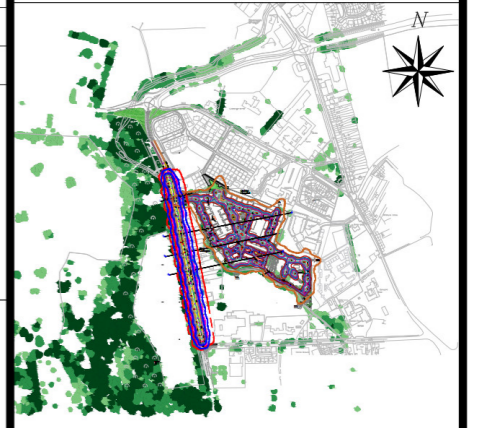

SCALE: NTS

Rev	By	Date	Description
04	DM	04/24	Isolux

Drawing Status: PLANNING
 NOT CERTIFIED FOR CONSTRUCTION

Project Title: Proposed Residential Development, Port Road, Killarney, Co. Kerry

Drawing Title: Lighting Plan Assessment (5 of 7)

Client: Portal Asset Holdings

M.H.L. & Associates Ltd.
 Consulting Engineers

MHL

Unit 1b,
 The Atrium,
 Blackpool,
 Cork

Tel: 021-4840214
 Fax: 021-4840215
 E-Mail: info@mhl.ie

Designed: DM	Drawn: DM	Checked: BM
Scale: AS SHOWN	Date: APRIL 2024	
Job No: 18137HD	Drawing No: PR-MHL-LPA-P04	Revision: _04