


NOTES:

All dimensions in metres.
Do not scale from drawing.
For any discrepancies found please consult with design office.
This drawing should be read in conjunction with all contract drawings, documents and specifications.

LEGEND:

- Lighting Columns: A B C D
- Lighting Contours: [Color-coded lines]
- Treescape Heights (m) Blueskyreland surveys: [Color-coded boxes for height ranges: 0.3-4.2, 4.2-6.4, 6.4-9.6, 9.6-13.9, 13.9-25.9]
- Estimated son Lighting Spread extents: [Red line]
- Proposed M4 LED Lighting Spread extents: [Blue line]
- Cross section: [Black line]

SCALE: 1:500 @A3

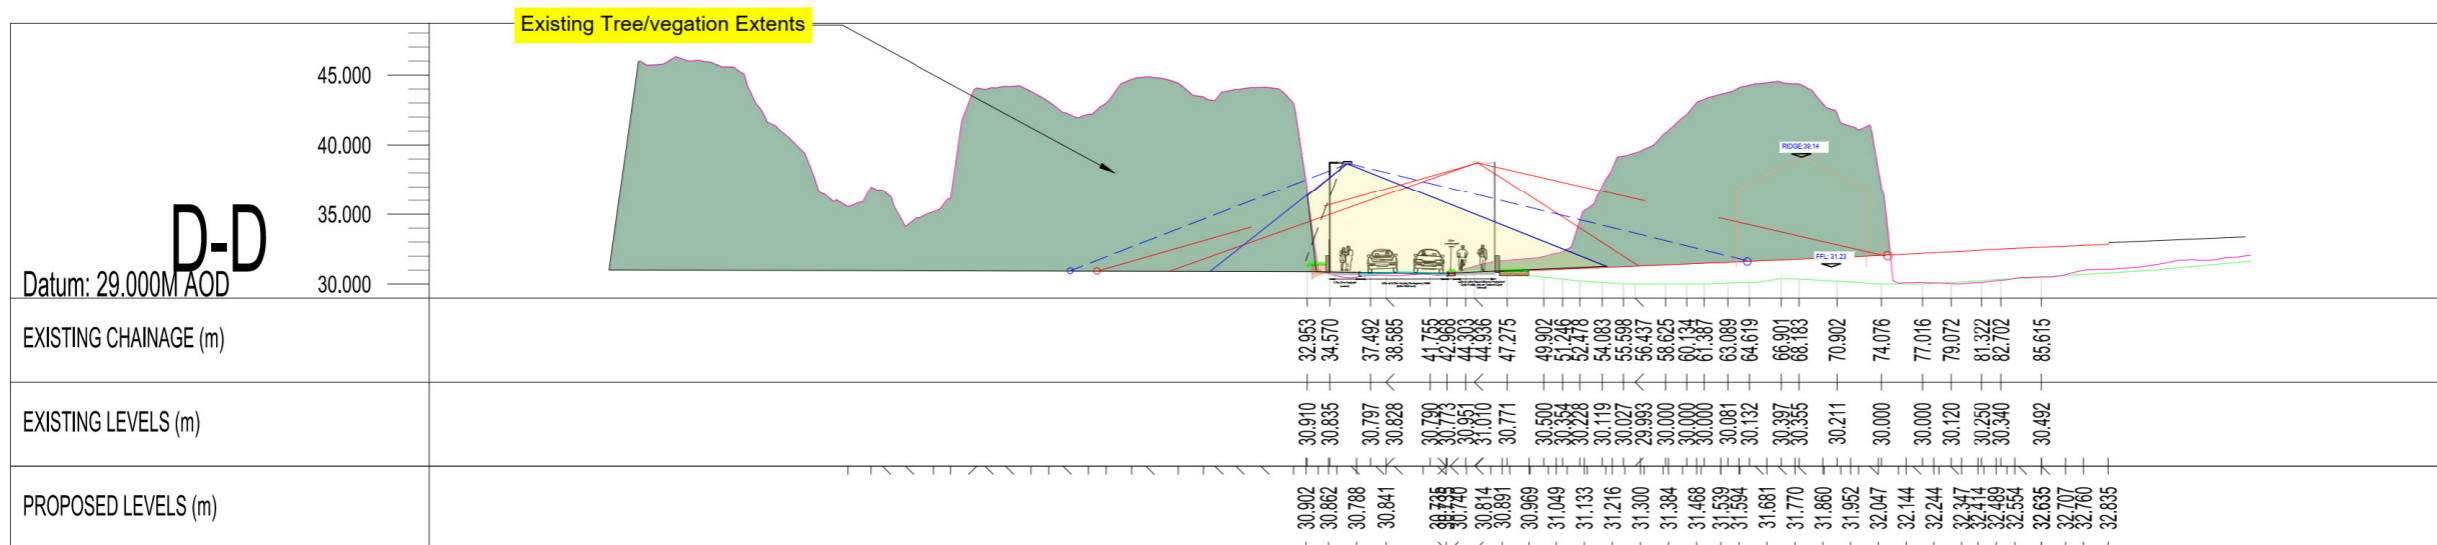

SCALE: NTS



Rev	By	Date	Description
04	DM	04/24	Isolux

Drawing Status: **PLANNING**
NOT CERTIFIED FOR CONSTRUCTION

Project Title: Proposed Residential Development, Port Road, Killarney, Co. Kerry


Drawing Title: Lighting Plan Assessment (7 of 7)

Client: Portal Asset Holdings

M.H.L. & Associates Ltd.
Consulting Engineers

Unit 1b, The Atrium, Blackpool, Cork
Tel: 021-4840214
Fax: 021-4840215
E-Mail: info@mhl.ie

Designed: DM	Drawn: DM	Checked: BM
Scale: AS SHOWN	Date: APRIL 2024	
Job No: 18137HD	Drawing No: PR-MHL-LPA-P06	Revision: _04

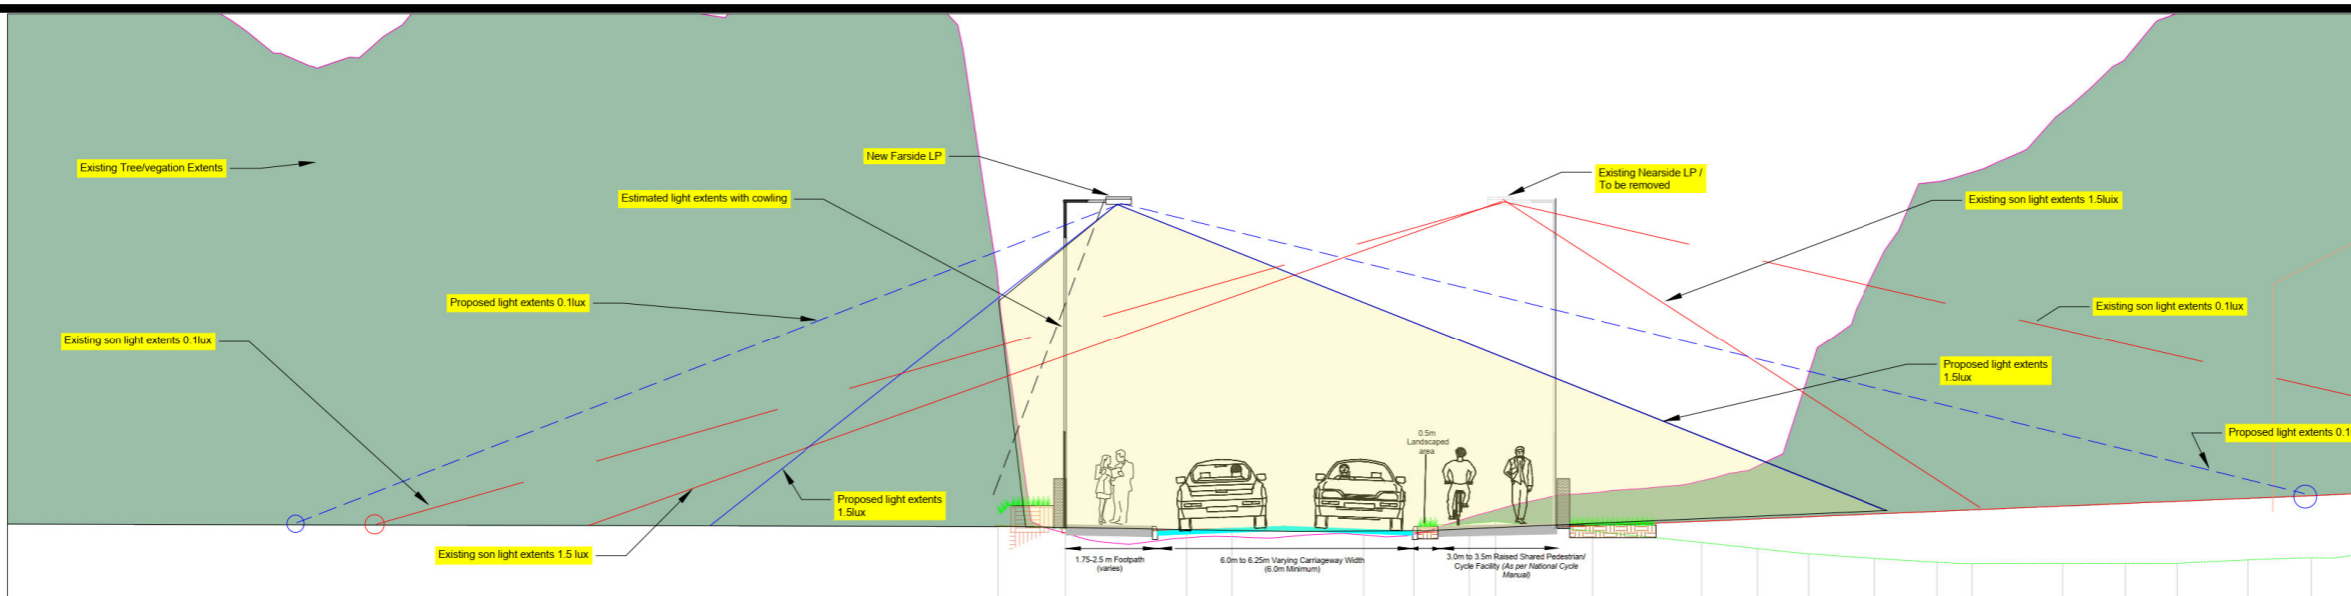

SCALE: NTS